


LEGEND

HH = HEADER HEIGHT	REFR = REFRIGERATOR	W = WALL HEATER	TWH = TANKLESS WATER HEATER	
LOW CASEWORK	WD = WASHER/DRYER COMBO	OVEN = OVEN	GM = GAS METER	WH = WATER HEATER
UPPER CASEWORK	W = WASHER	DW = DISH WASHER	EM = ELECTRIC METER	WS = WATER SOFTENER
FULL HEIGHT CASEWORK	D = DRYER	TC = TRASH COMPACTOR	SC = SOLAR COMPONENTS	FD = FLOOR DRAIN
CLG = CEILING HEIGHT	R = RANGE	FURN = FURNACE	EP = ELECTRICAL PANEL	

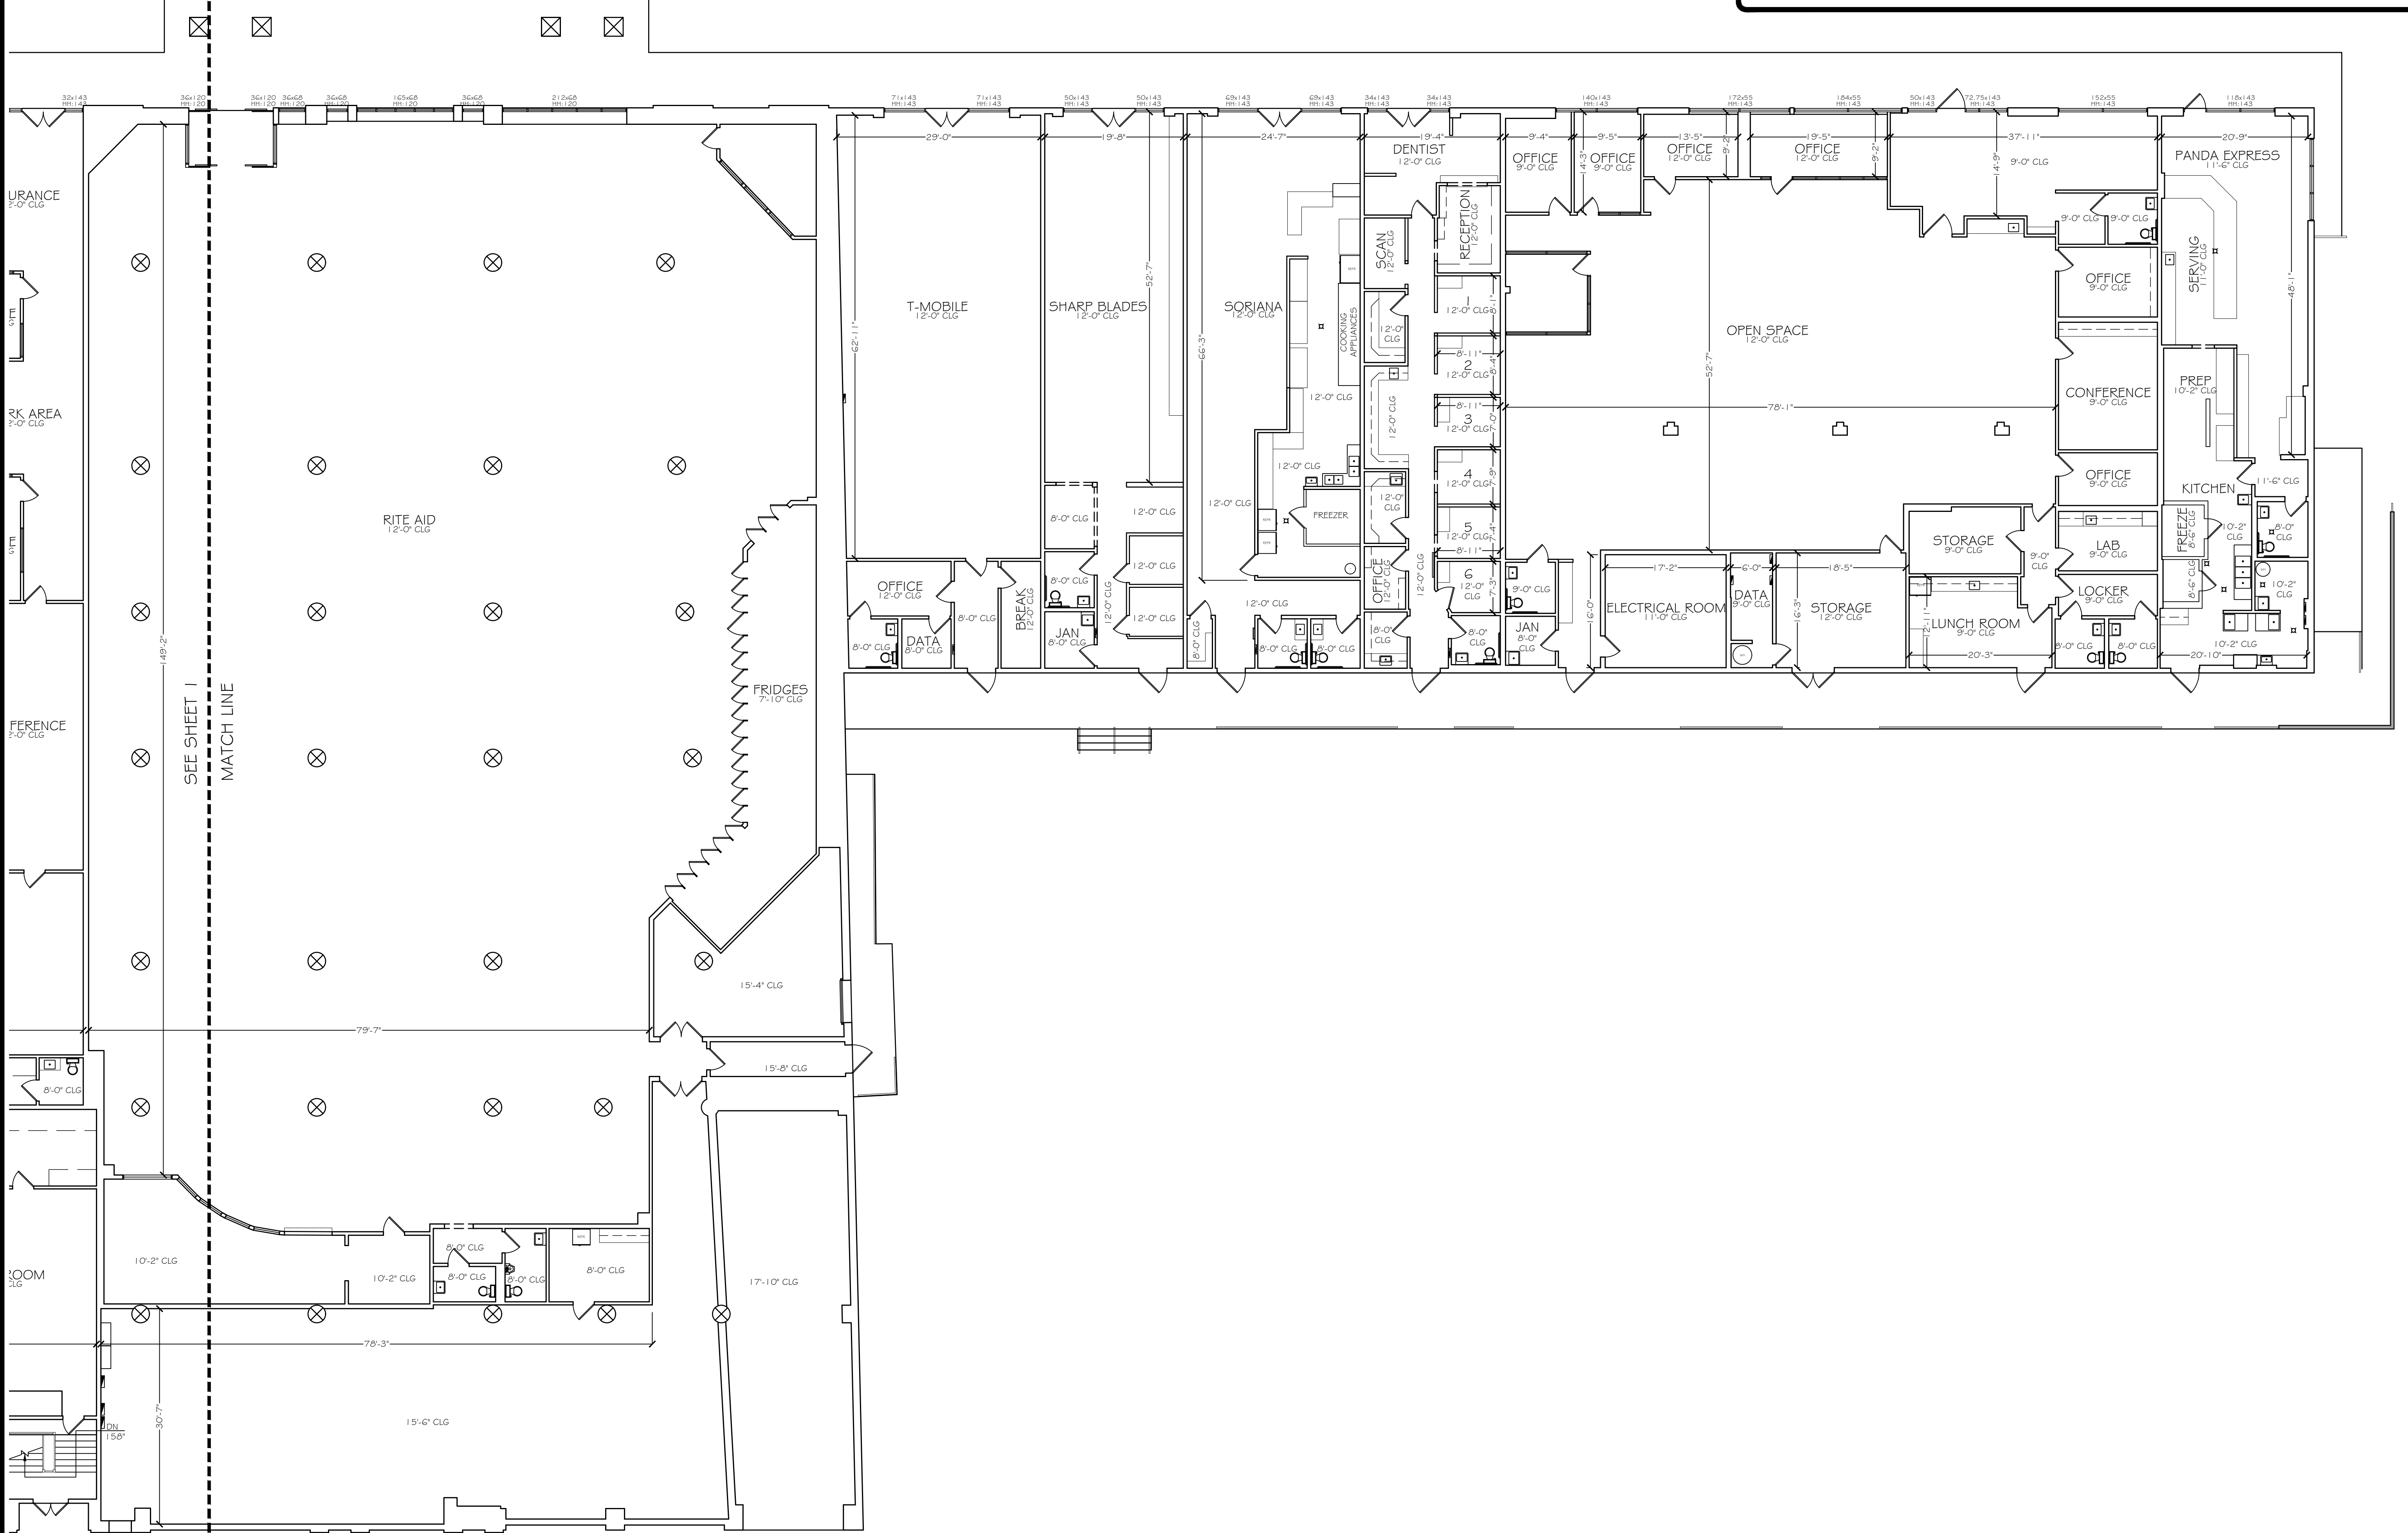

PPM
PRECISION PROPERTY MEASUREMENTS
 3626 E. PACIFIC COAST HIGHWAY | 2ND FLOOR
 LONG BEACH CA | 90804
 T 562.621.9100
 F 888.698.2966
 WWW.PPMCO.NET




PREPARED FOR
 CLIENT

PLAN TYPE
FLOOR PLAN

PROJECT NAME
IN-LINE RETAIL

PROJECT ADDRESS
 STREET
 CITY, ST 00000

All plans created by Precision Property Measurements use PPM's own field surveying for boundary purposes (i.e. this is a Field Code 80727). All data plans created by PPM do not include the determination of any property line, and as such do not constitute legal approvals. (See also: Field Code 80727-01, 80727-02, 80727-03, 80727-99, 80727-100.) All floor plans created by PPM are intended to be used as a reference for design and construction and should not be considered a substitute for the services of a licensed structural engineer or licensed architect. PPM makes every reasonable effort to ensure the accuracy of its data and plans, but does not warrant the accuracy of its data and plans. Therefore, users of all data and plans created by PPM should consult with a licensed structural engineer or licensed architect before using any data and plans created by PPM. PPM's liability is limited to the amount of the fee paid to PPM.

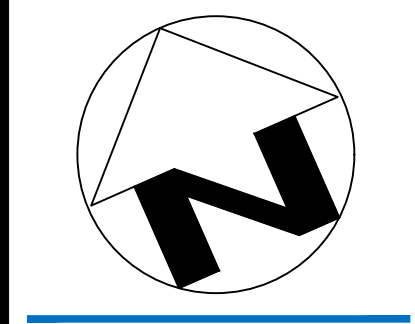

SCALE
 3/32" = 1'-0"
 PROJECT
 XXXX_XX
 APPROVED BY
 XX
 DATE
 00/00/00
 SHEET
 2 of 3

